

Notes:

Tonah: Ususan

### AS - BUILT DRAWING



UNIVERSITI KEBANGSAAN MALAYSIA  
KAMPUS BARU, 43600 SEREMBAN, NEGERI SEMBILAN  
TEL : 03-8951 3000 FAX : 03-8951 3001  
WWW.UKM.MY

Mah: Konektor

#### PL DEVELOPMENT CONSULT

PL DEVELOPMENT CONSULT  
100, Jalan Lintas  
Kuala Lumpur, Malaysia  
TEL : 03-4388 2411 FAX : 03-4388 1410

Juruaun Struktur & soil

#### BERKAITAN CONSULTING ENGINEERS

BERKAITAN CONSULTING ENGINEERS  
100, Jalan Lintas  
Kuala Lumpur, Malaysia  
TEL : 03-4377 7000 FAX : 03-4377 7001

Juruaun Mekanikal & Elektrikal

#### PERKONSALITI AKTIVITI

PERKONSALITI AKTIVITI  
100, Jalan Lintas  
Kuala Lumpur, Malaysia  
TEL : 03-4388 2411 FAX : 03-4388 1410

Juruaun Botani

#### JURUAUN BUNYAN UTAMA

JURUAUN BUNYAN UTAMA  
100, Jalan Lintas  
Kuala Lumpur, Malaysia  
TEL : 03-4388 2411 FAX : 03-4388 1410

#### ADC AKITEK SDN

PERANCANGAN DAN PERSEKUTUAN PERANCANGAN DAN PERSEKUTUAN PERANCANGAN  
SIA BERKAITAN SDN, JALAN BUKU ALAM, LAMPUNG BARU, 52000  
BANDAR LAMPUNG, MALAYSIA TEL : 03-5881 0200 FAX : 03-5881 2700

Kontraktor Elektrik :




Tajuk Projek:  
CALANGAN MEMBINA BANGUNAN  
PALERES DAN BUNYAN,  
UNIVERSITI KEBANGSAAN MALAYSIA,  
BANGI, SELANGOR DANIL EREMAN.

Tajuk: Lulusan

#### ELECTRICAL SERVICES EXTERNAL TELEPHONE MANHOLE SITE PLAN

Ditulis Oleh: TAMALI  
Ditawar Oleh: MR. GHAN  
Sisid: AS SHOHIN

Tarikh: MARCH 2011  
No. Lulusan :  
SOLUKM/INDSPP/PA/04/07/101 01

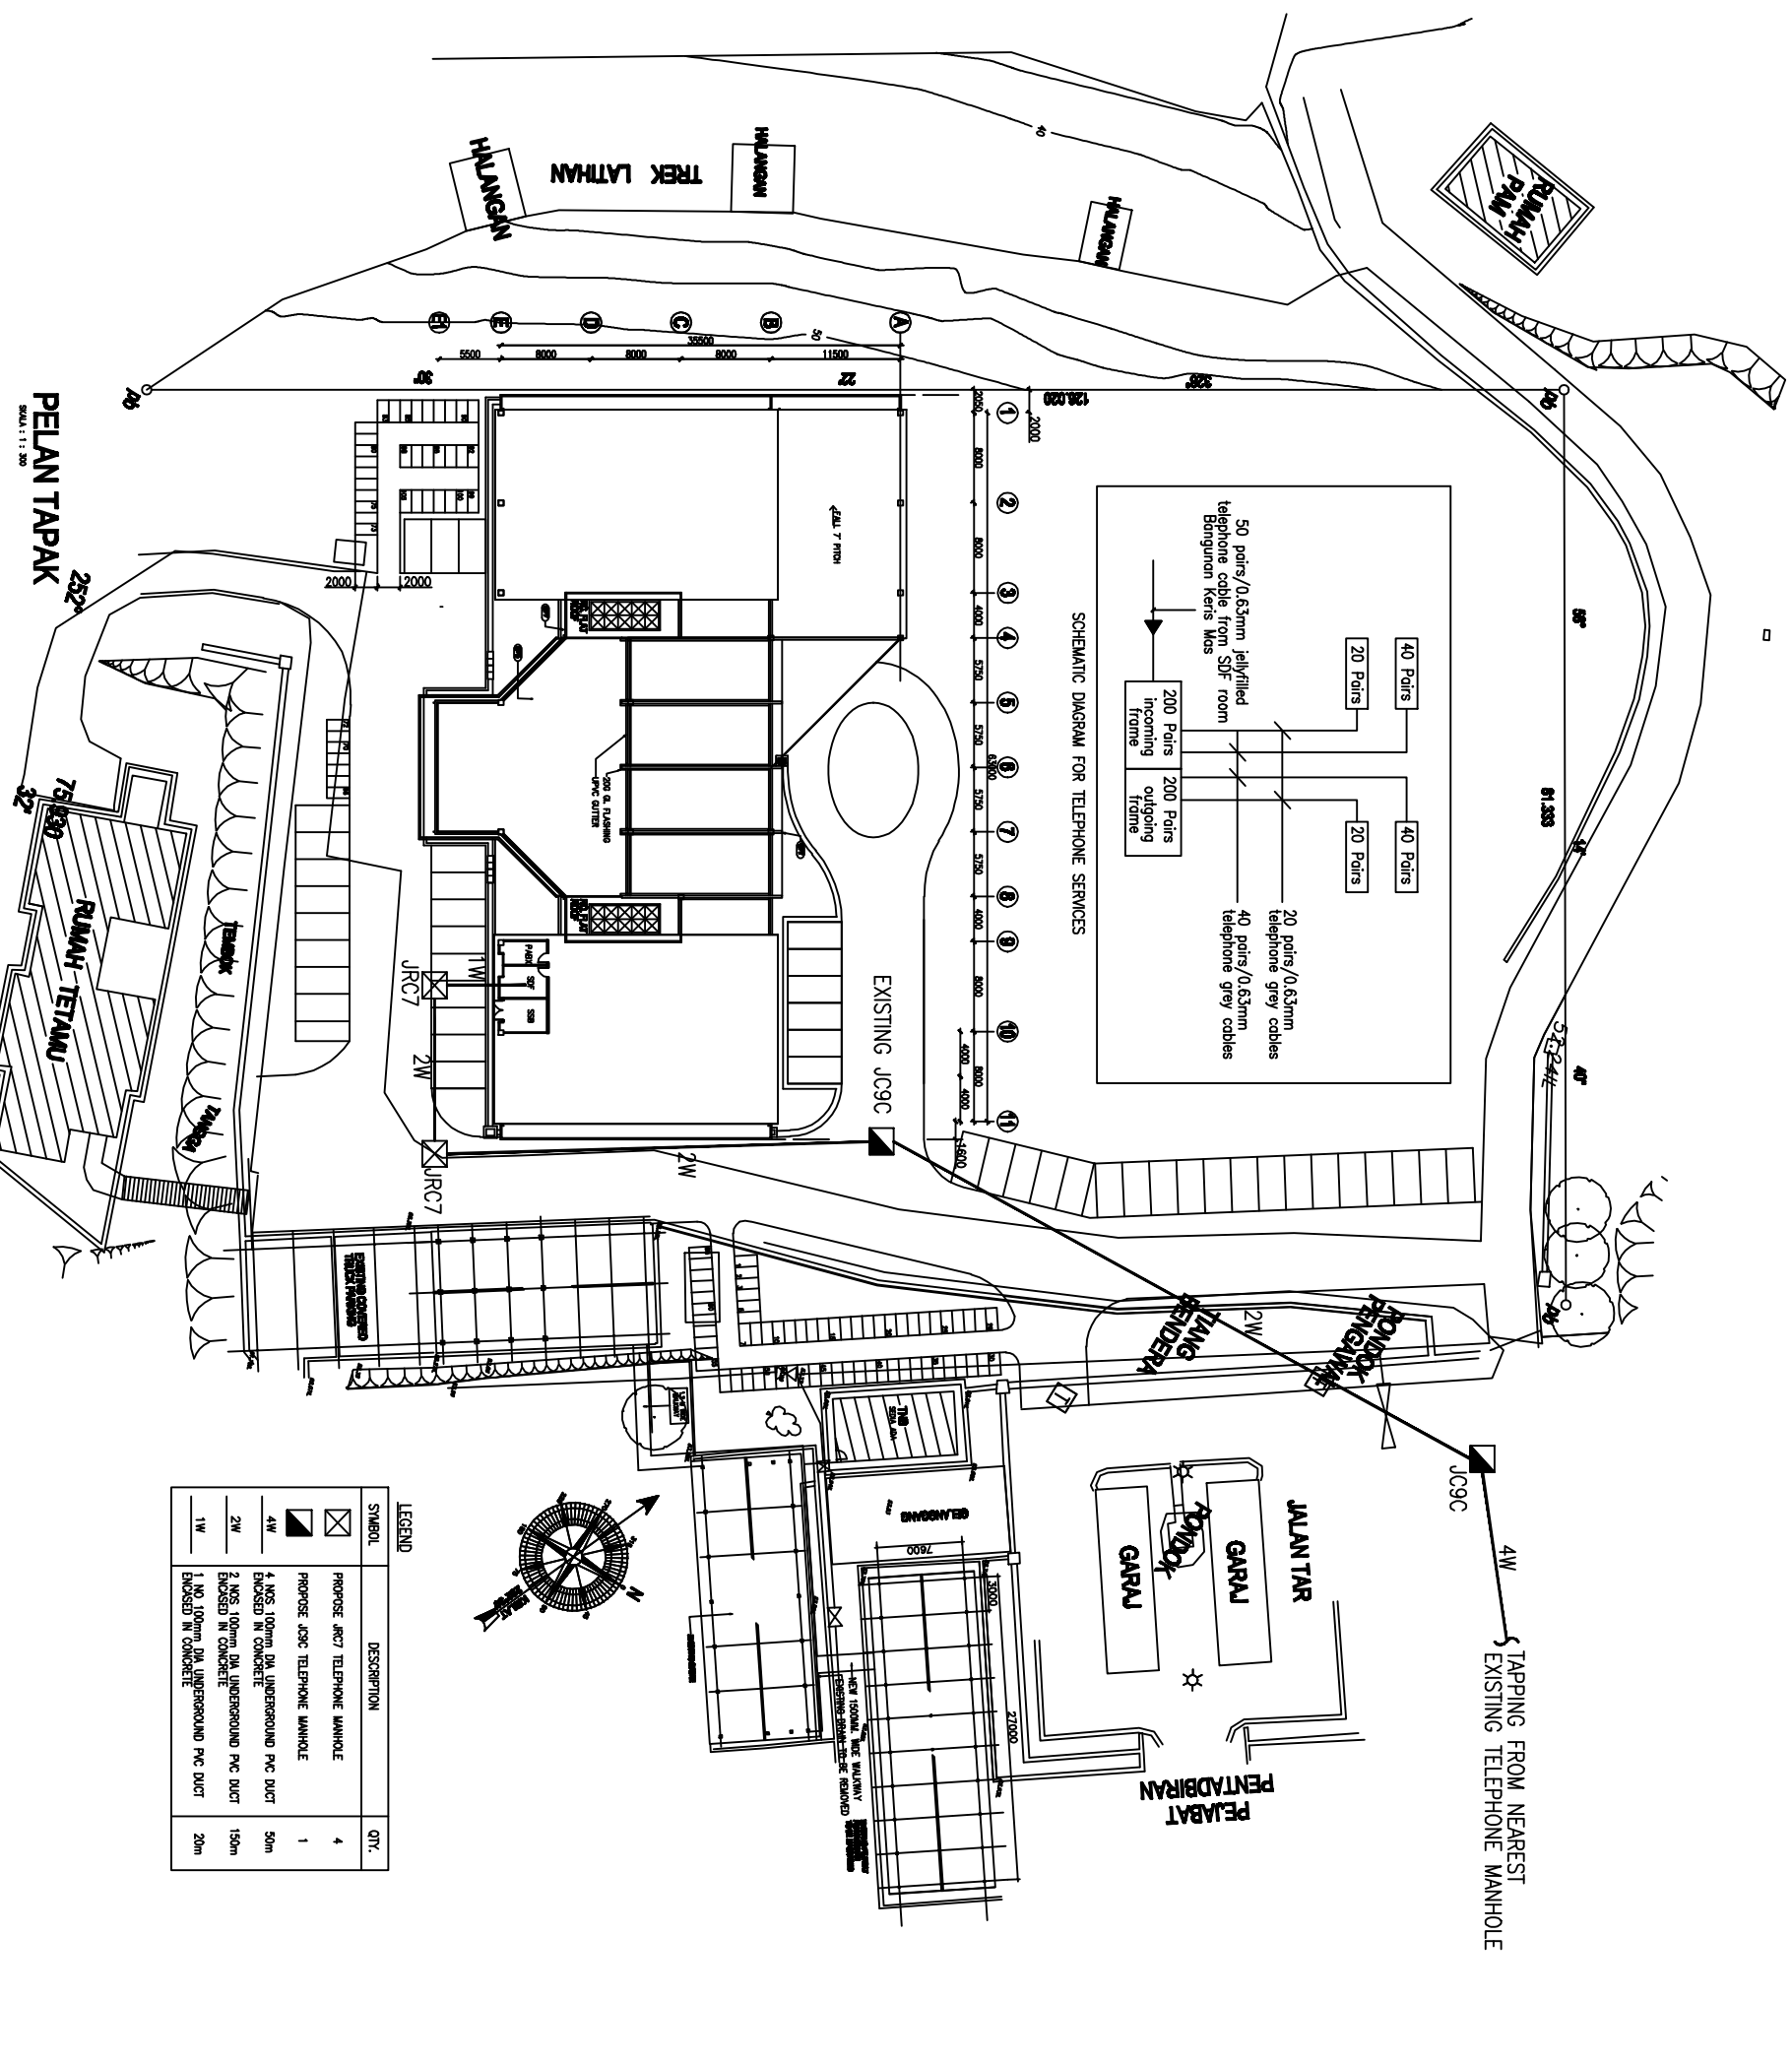

LEGEND

SYMBOL	DESCRIPTION	QTY.
☒	PROPOSE JC9C TELEPHONE MANHOLE	4
▣	PROPOSE JC9C TELEPHONE MANHOLE	1
4W	4 NOS. 100mm DIA UNDERGROUND PVC DUCT ENCASED IN CONCRETE	50m
2W	2 NOS. 100mm DIA UNDERGROUND PVC DUCT ENCASED IN CONCRETE	150m
1W	1 NO. 100mm DIA UNDERGROUND PVC DUCT ENCASED IN CONCRETE	20m

PELAN TAPAK  
SKALA 1:200